


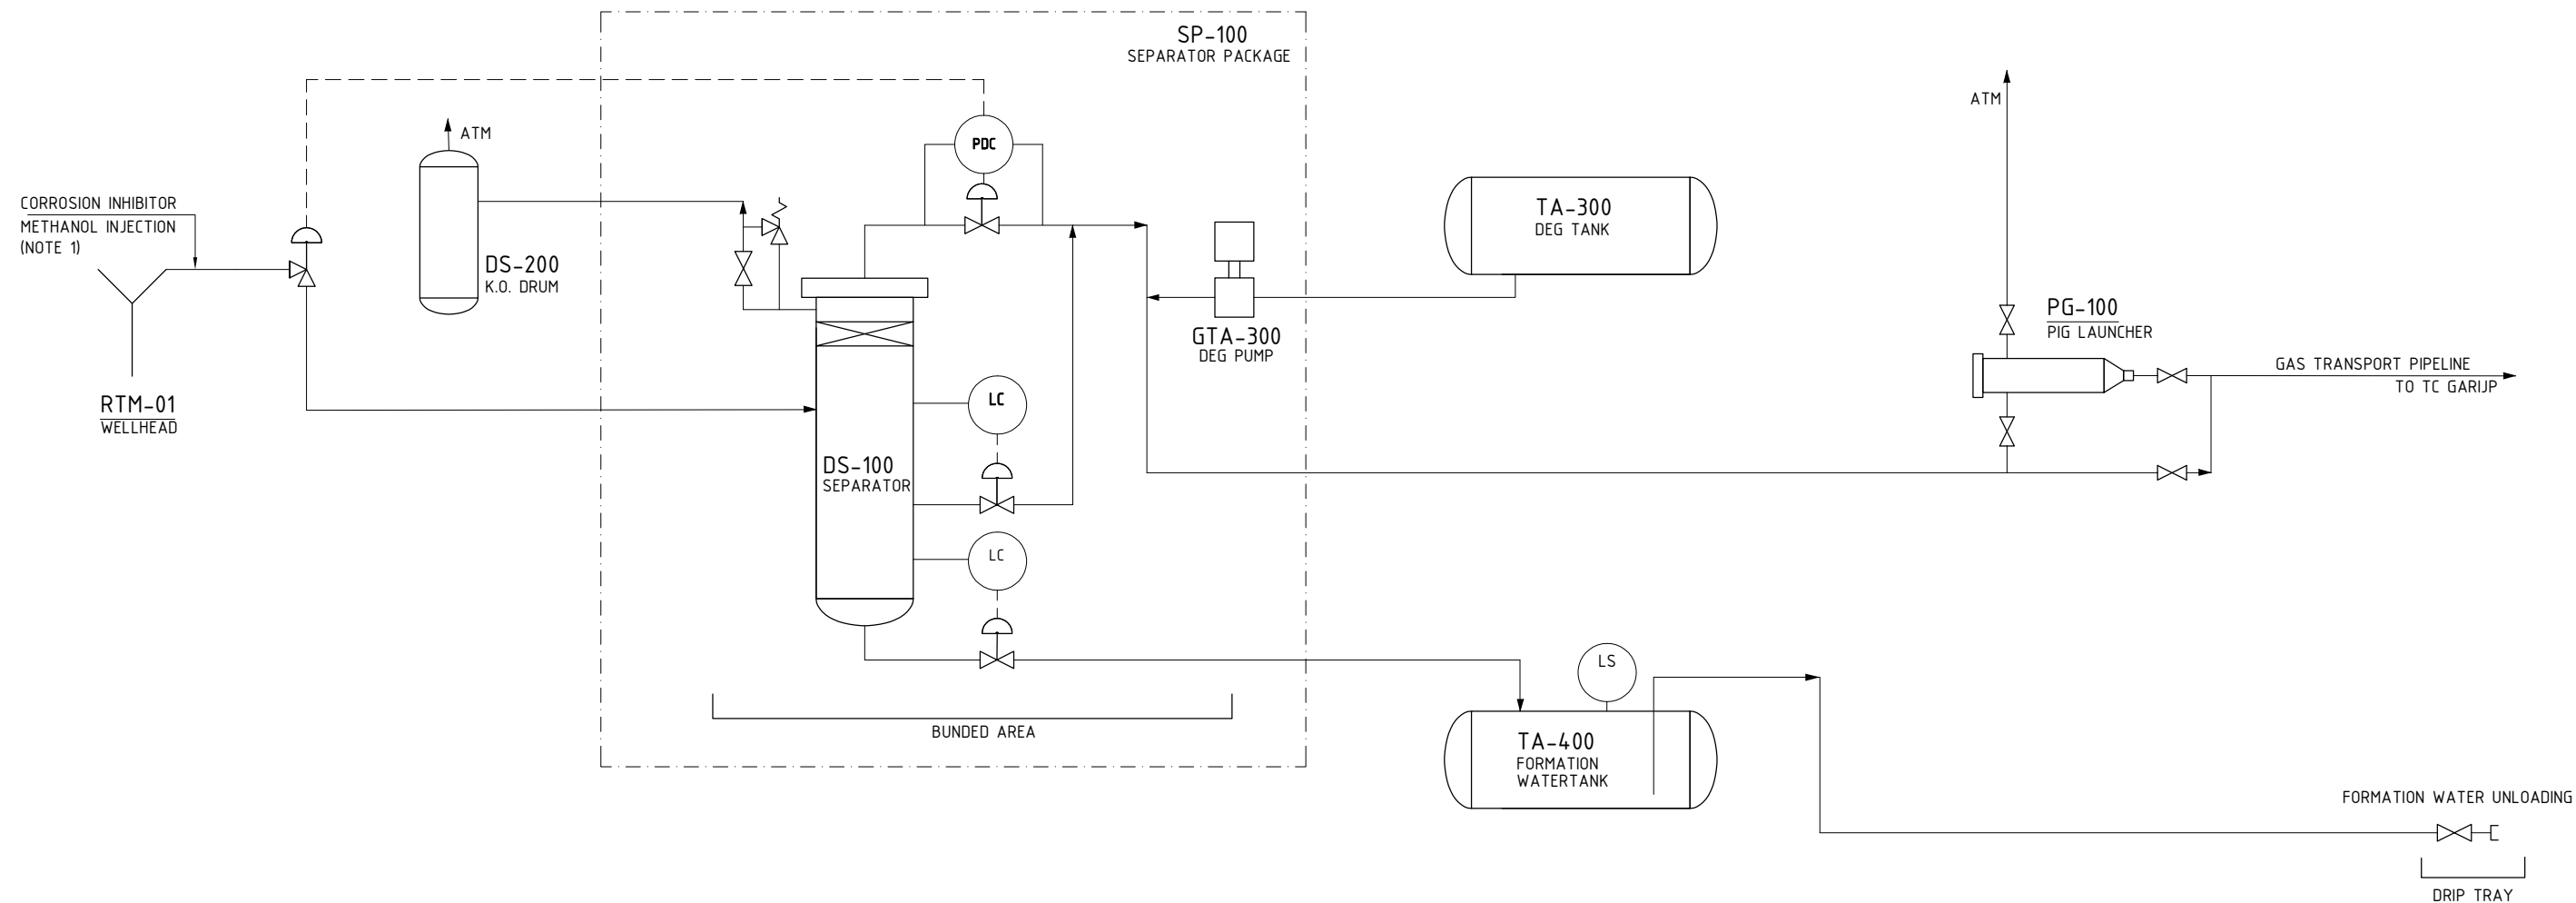

GENERAL NOTES

1- METHANOL INJECTION DURING START-UP

HOLDS

0	23-01-2017	FOR PERMITTING	5.1.2.e			
REV.	DATE	DESCRIPTION	DRWN	CHK'D	APPR.	

LOCATION:	ROTTUM		
WELLS:	RTM-01		
TITLE: PROCESS FLOW DIAGRAM			
REF. No.:		CAD No.:	
VOG-15364-NLM-D-R-01001-01			
SCALE:	SIZE	DRAWING NUMBER:	SHEET:
NTS	A2	1-32-NLM001-3-31-001	001