


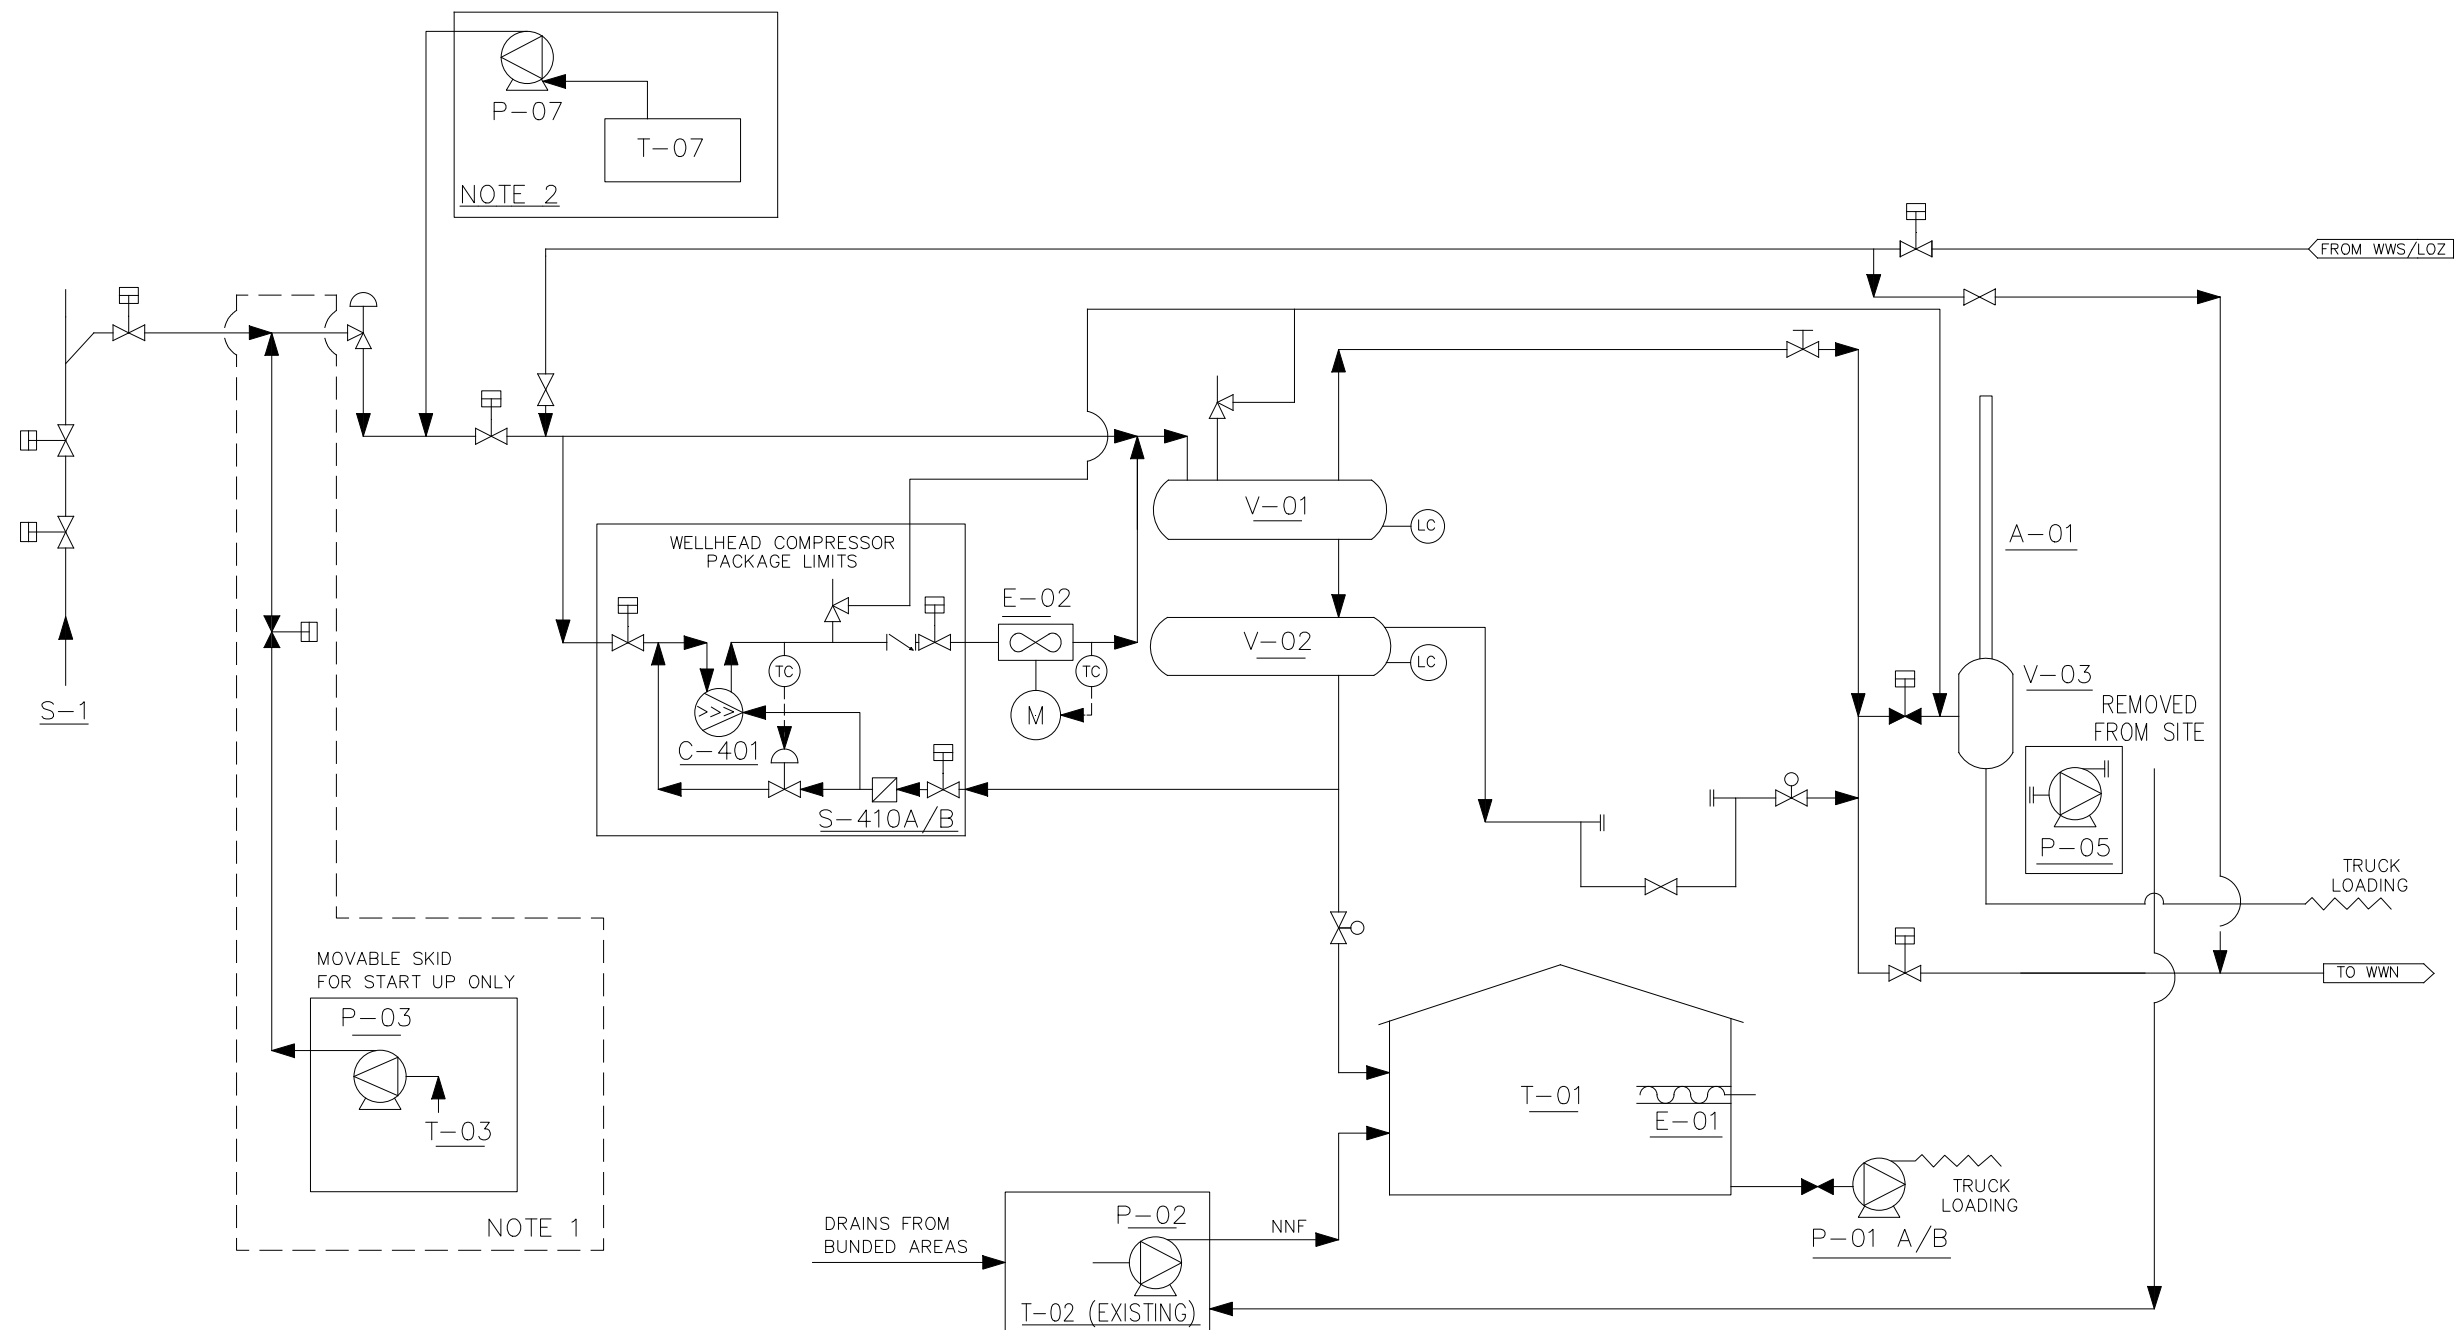

S-1
WELLHEAD

V-01
GAS/LIQUID SEPARATOR
DIAMETER: 1.00 M
LENGTH: 3.50 M
VOLUME: 2.5 M3

V-02
CONDENSATE/WATER SEPARATOR
DIAMETER: 1.00 M
LENGTH: 3.50 M
VOLUME: 2.5 M3

P-02
DRAIN PIT PUMP
CAPACITY 15 M3/HR
DIFF.HEAD: 16 M.LIQ

T-01
WATER STORAGE TANK
DIAMETER: 6.00 M
LENGTH: 4.50 M
VOLUME: 120 M3

T-02
DRAIN PIT
LENGTH: 15.0 M
HEIGHT: 1.60 M
WIDTH: 3.30 M
VOLUME: 79.2 M3

T-03
METHANOL TANK (PORTABLE)
VOLUME: 0.6 M3

E-02
GAS COOLER
DUTY: 743 KW
AREA: 1333 M2

P-07
CI PUMP
CAPACITY: 0.22 L/HR
DIFF.HEAD: 140 BARG

P-01 A/B
WATER DISCHARGE PUMP
CAPACITY: 25 M3/HR
DIFF.HEAD: 16 M.LIQ

V-03
VENT SCRUBBER
DIAMETER: 1.00 M
LENGTH: 1.55 M
VOLUME: 1.5 M3

P-03
METHANOL INJECTIN PUMP
CAPACITY: 0.08 M3/HR
DIFF.HEAD: 280 BARG

P-05 (REMOVED)
SLUDGE PUMP
CAPACITY: 9 M3/HR
DIFF.HEAD: 11 M.LIQ

A-01
VENT STACK
HEIGHT: 12.0 M

E-01
ELECTRIC HEATER
DUTY: 3 KW

C-401
WELLHEAD COMPRESSOR
CAPACITY: 125.000 NM3/DAY
DIFF.HEAD: 14 BAR
DUTY: 206 KW

T-07
CI TANK (PORTABLE)
VOLUME: 0.3 M3

NOTES

- TEMPORARY INSTALLATION FOR FLOWBACK PERIOD.
- TEMPORARY INSTALLATION AS NEEDED FOR CORROSION.

LOCATION: SPRANG

WELLS:

TITLE:
PROCESS FLOW DIAGRAM

REF. No.: _

CAD No.: 200-1041

SCALE: NONE

SIZE A1

DRAWING NUMBER: 1-58-SPR-3-31-003

SHEET: 001

1 14-02-19 AS BUILT - 1048/1028-MOC-2018

0 22-04-18 AS BUILT

REV DATE

DESCRIPTION

5.1.2.e

DRWN

CHK'D

APPR.