


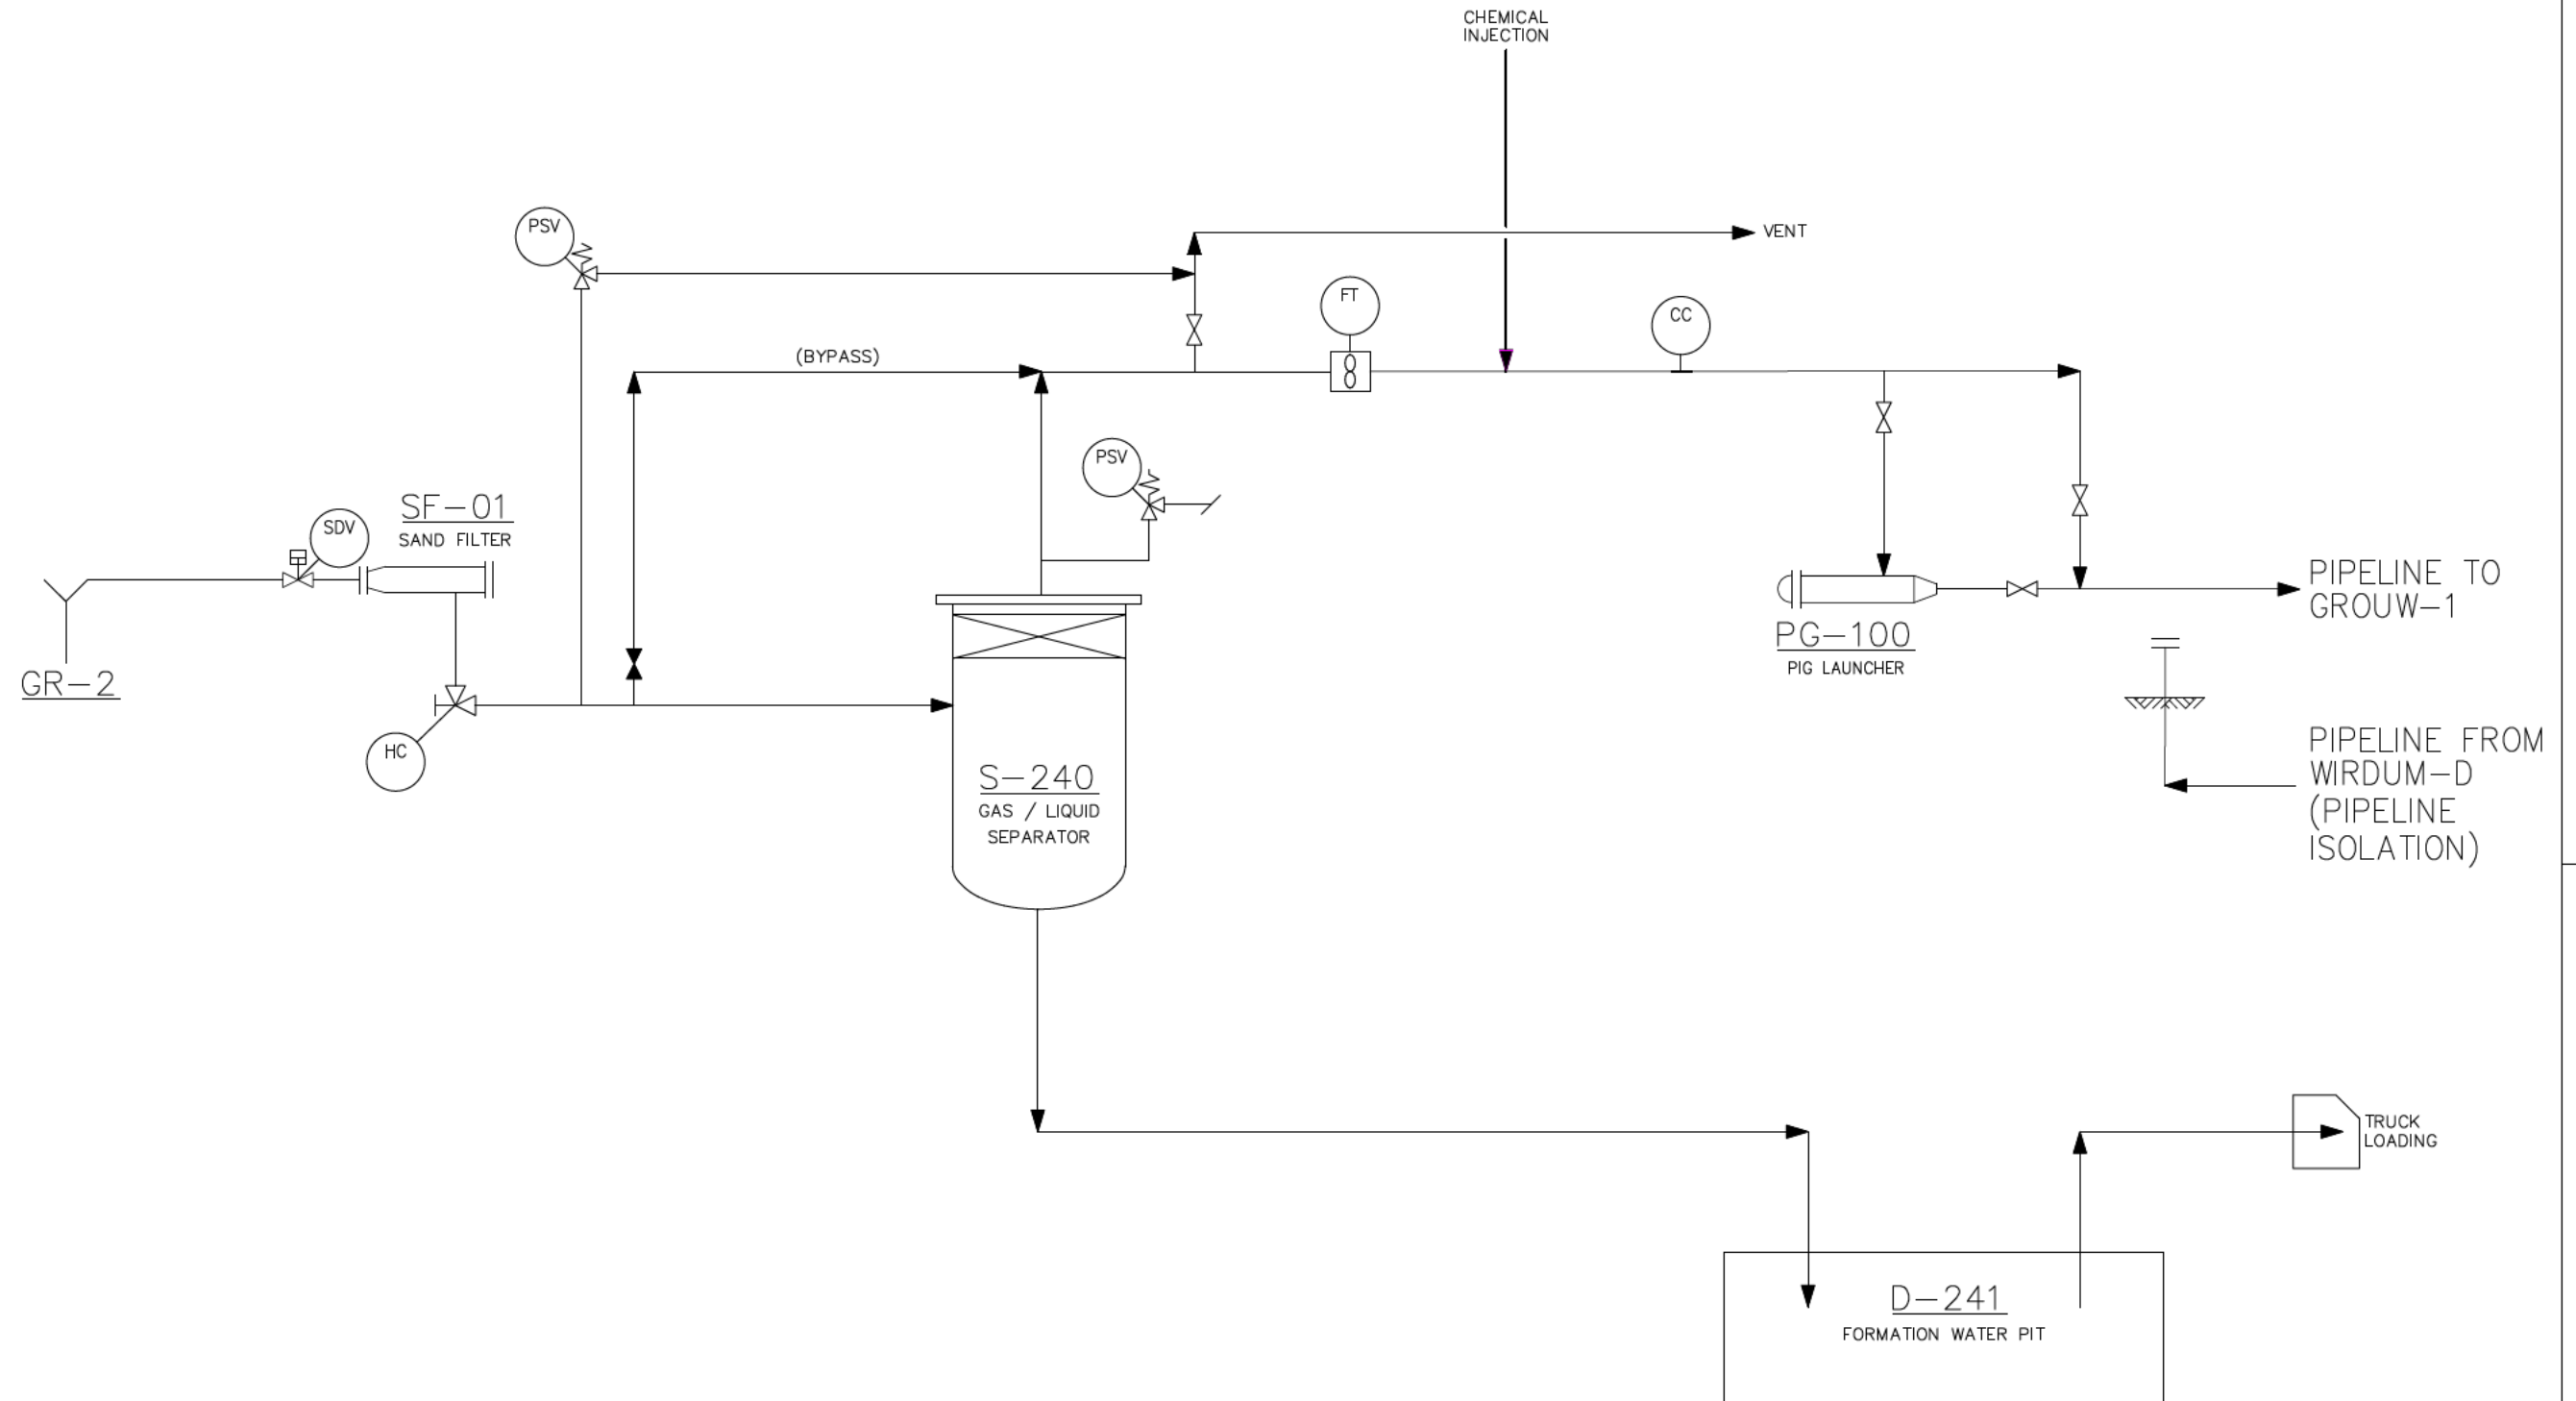

THIS DRAWING WAS AS-BUILT BASED ON INFORMATION PROVIDED BY THE OWNER. PLEASE CONFIRM ALL ORIENTATIONS, DISTANCES, DIMENSIONS, VALVES, SIZES, RATINGS, ETC. PRIOR TO USING THIS INFORMATION FOR ANY NEW CONSTRUCTION.

OPMERKINGEN

1: CI-INJECTIE
CI-INJECTIE OP WATERBASIS
BESTAANDE UIT: 75% WATER, 24% METHANOL, 1% CORROSION INHIBITOR

ALL TAG NUMBERS HAVE PREFIX 49

REV.	DATE	DESCRIPTION	DRWN	CHK'D	APPR.
4	02-07-24	AS-BUILT (TAP23273)			
3	15-08-05	EERSTE UITGAVE VERMILION			

5.1.2.e



LOCATION:

GROUW 2

TITLE:

PROCESS FLOW DIAGRAM

CAD NR.:

-

DRAWING NUMBER:

1-30-GR002-3-31-004